
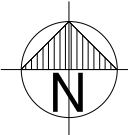
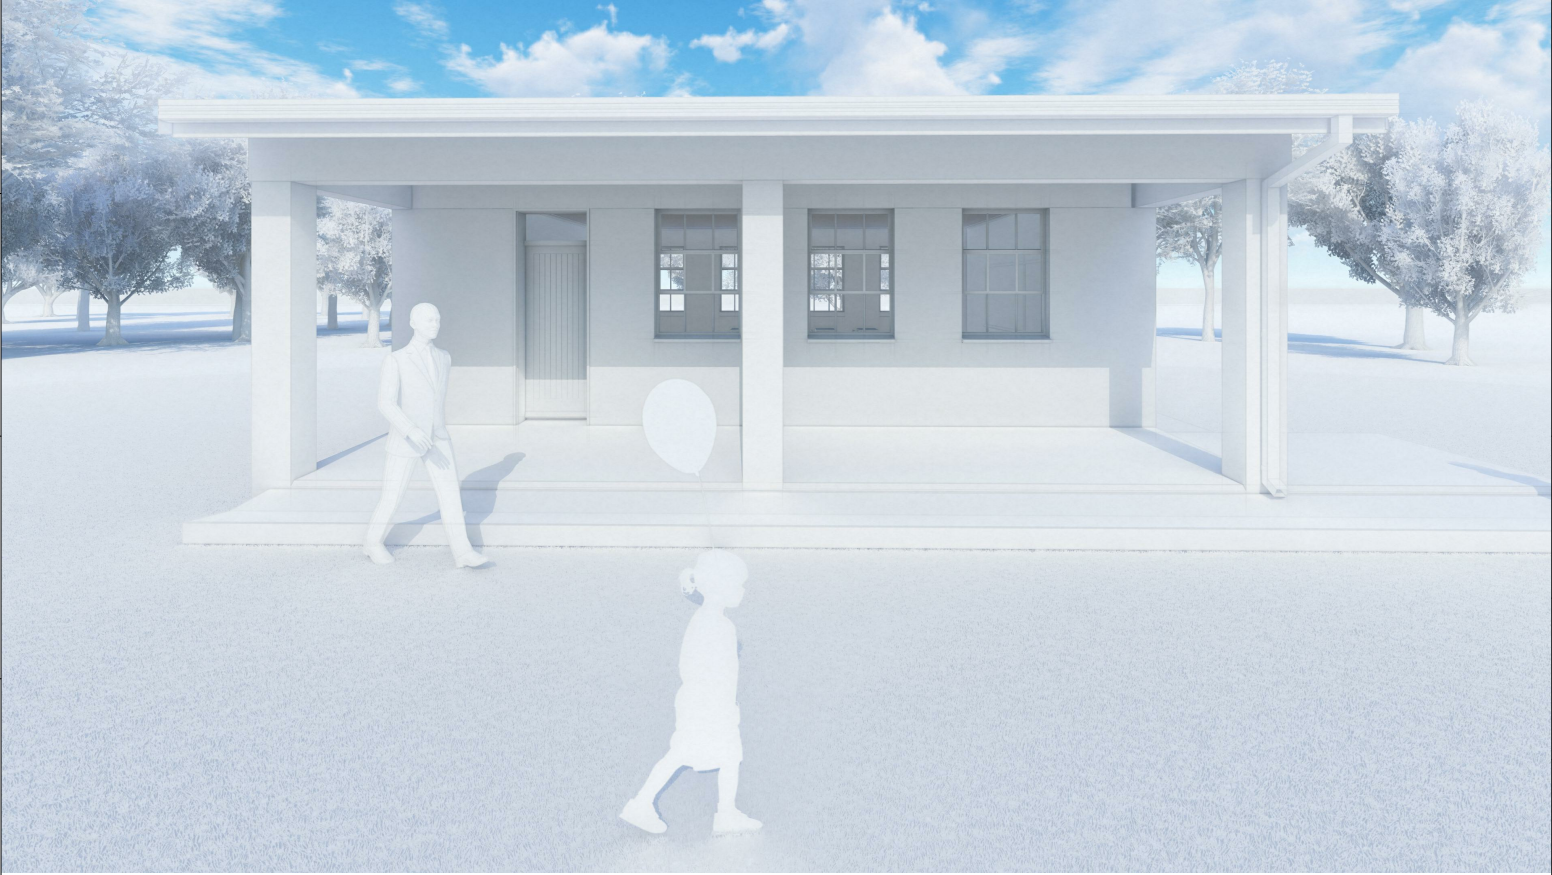



<div>CLIENT</div> <div><div>basic education Department: Basic Education REPUBLIC OF SOUTH AFRICA</div></div> <div>CONTACT INFORMATION: PERSON: NUMBER: EMAIL:</div>		<div>BUILDING CODE: EE1</div> <div>BUILDING TYPE: SINGLE CLASSROOM BLOCK</div>		SDP PLAN			
<div>CUSTODIAN</div> <div>INSERT CUSTODIAN LOGO HERE</div> <div>CONTACT INFORMATION: PERSON: NUMBER: EMAIL:</div>							
<div>IMPLEMENTING AGENT</div> <div>INSERT IMPLEMENTING AGENT LOGO HERE</div> <div>CONTACT INFORMATION: PERSON: NUMBER: EMAIL:</div>							
<div>PRINCIPAL AGENT</div> <div>INSERT PRINCIPAL AGENT LOGO HERE</div> <div>CONTACT INFORMATION: PERSON: NUMBER: EMAIL:</div>							
<div>ARCHITECT</div> <div>INSERT ARCHITECT LOGO HERE</div> <div>CONTACT INFORMATION: PERSON: NUMBER: EMAIL:</div>		<div>IMPLEMENTATION PROGRAM BUILDING DOCUMENTATION PROGRAM DESCRIPTION</div>		SCHOOL INFORMATION		SCHOOL NAME	
<div>MECHANICAL & ELECTRICAL</div> <div>INSERT MECHANICAL & ELECTRICAL LOGO HERE</div> <div>CONTACT INFORMATION: PERSON: NUMBER: EMAIL:</div>				LOCATION:	LOCATION		
<div>CIVIL & STRUCTURAL</div> <div>INSERT CIVIL & STRUCTURAL LOGO HERE</div> <div>CONTACT INFORMATION: PERSON: NUMBER: EMAIL:</div>				GPS:	GPS CO-ORDINATES		
<div>OTHER</div> <div>INSERT OTHER LOGO HERE</div> <div>CONTACT INFORMATION: PERSON: NUMBER: EMAIL:</div>				EMIS:	EMIS NUMBER		
				PROGRAM:	IMPLEMENTATION PROGRAM		
				PROJ No.:	0000		

COMPRISE NOTE

- THIS DRAWING IS SUBJECT TO COPYRIGHT AND MAY NOT BE REPRODUCED, IN WHOLE OR PART, OR IN ANY MANNER WHATSOEVER WITHOUT WRITTEN PERMISSION FROM THE ARCHITECT.
- ALL WORK TO BE CARRIED OUT STRICTLY IN ACCORDANCE WITH MUNICIPAL AND/OR LOCAL AUTHORITY REGULATIONS
- DO NOT SCALE THIS DRAWING. FIGURED DIMENSIONS TO BE TAKEN IN PREFERENCE TO SCALING DRAWING.
- ALL RELEVANT DETAILS, LEVELS, AND DIMENSIONS TO BE CHECKED ON SITE PRIOR TO COMMENCEMENT OF WORK
- ANY DISCREPANCIES TO BE BROUGHT TO THE ATTENTION OF THE ARCHITECT.
- DIMENSIONS ARE INDICATED IN MILLIMETERS.

CLIENT



basic education
Department:
Basic Education
REPUBLIC OF SOUTH AFRICA

REV	DATE	DESCRIPTION

PRINCIPAL AGENT

PRINCIPAL AGENT LOGO HERE

DICIPLINE

ARCHITECT LOGO HERE

PROJECT DESCRIPTION	TITLE	
DOCUMENT STATUS	DOCUMENT STATUS	0000_AR_EE1_200
DRAWING NUMBER	DWG	CHK
DATE	01/01/23	SCALE

NOTE: FOR ALL FINISH CODES, REFER TO FINISHING SCHEDULES 1701-AR-580/581

NOTE: FOR RAINWATER DOWNPIPES AND TANK POSITIONS, REFER TO SDP DETAILS

NOTE: WALL & DOOR / WINDOW OPENINGS TO SUIT HORIZONTAL BRICK COURSING

DOOR SCHEDULE


Door Type	Total
D1	1

WINDOW SCHEDULE

Window Type	Total
W1	4
W3	3

SCHEDULE OF AREAS

ROOM NAME	AREA
1. TYPICAL CLASSROOM	60.1m ²
GROSS BUILDING AREA	67.5m ²
2. VERANDAH	18.8m ²
TOTAL COVERAGE	86.3m ²

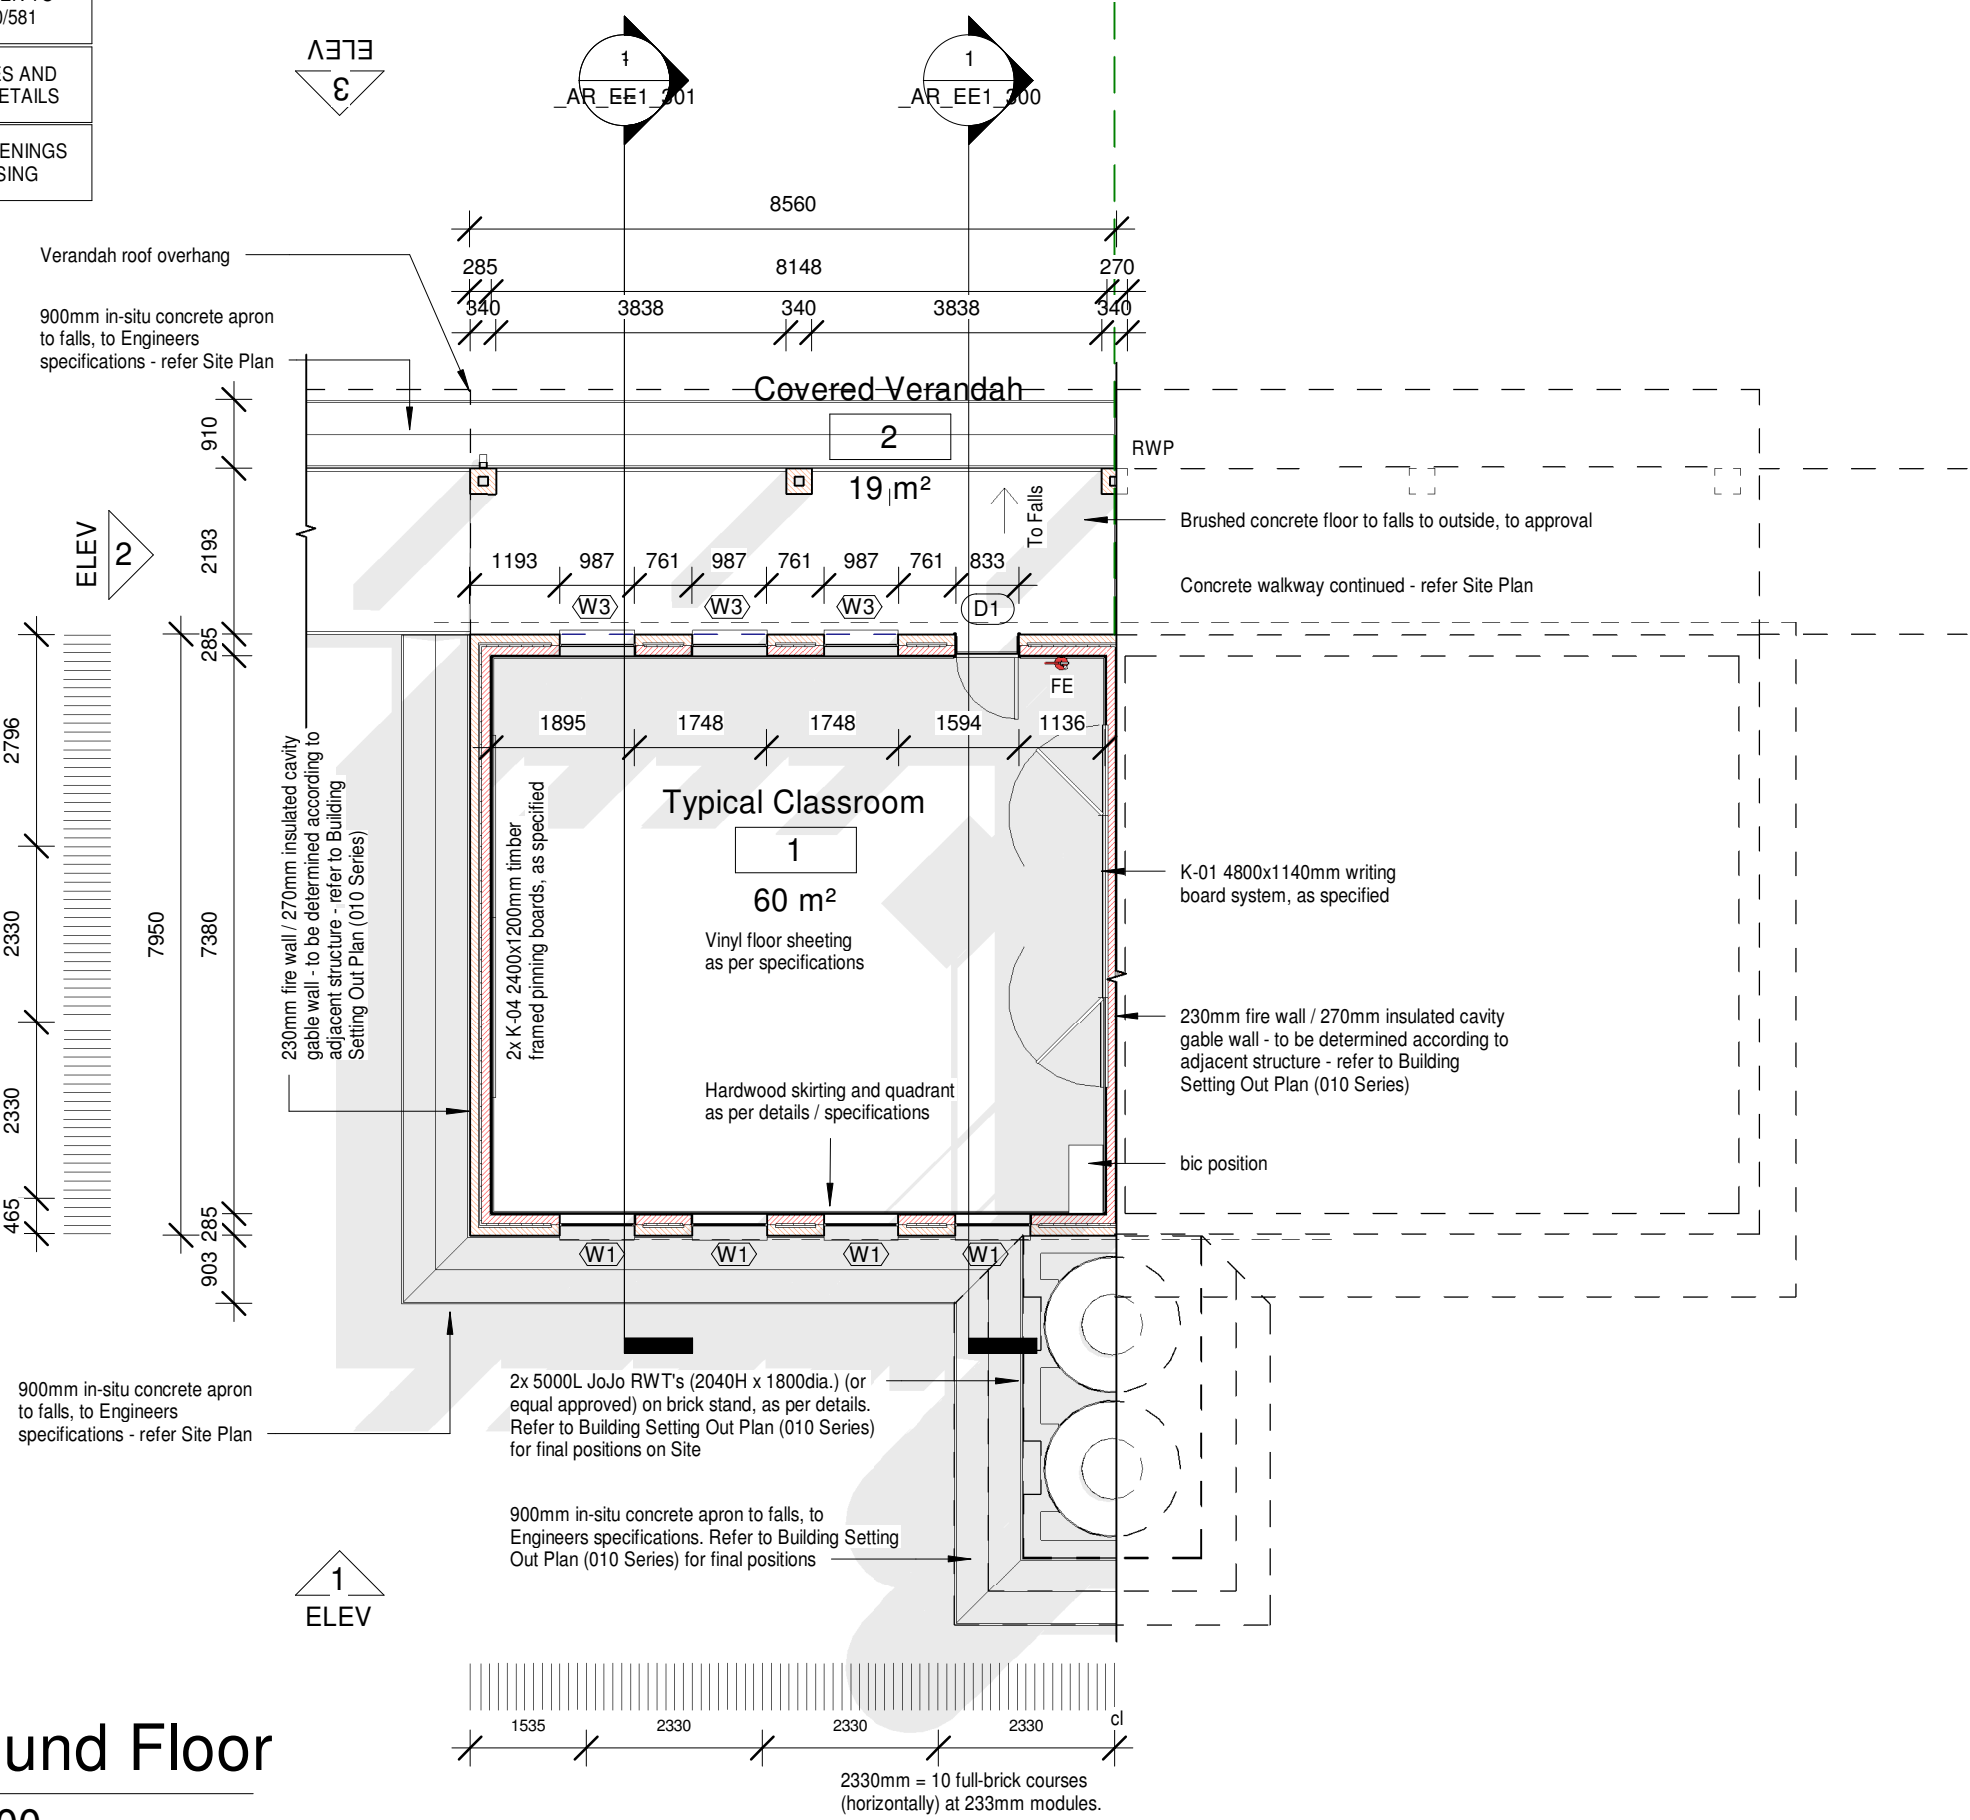

1 Ground Floor
1 : 100

THIS DRAWING IS SUBJECT TO COPYRIGHT AND MAY NOT BE REPRODUCED, IN WHOLE OR PART, OR IN ANY MANNER WHATSOEVER WITHOUT WRITTEN PERMISSION FROM THE ARCHITECT.
ALL WORK TO BE CARRIED OUT STRICTLY IN ACCORDANCE WITH MUNICIPAL AND/OR LOCAL AUTHORITY REGULATIONS.
DO NOT SCALE THIS DRAWING. FIGURED DIMENSIONS TO BE TAKEN IN PREFERENCE TO SCALING DRAWING.
ALL RELEVANT DETAILS, LEVELS, AND DIMENSIONS TO BE CHECKED ON SITE PRIOR TO COMMENCEMENT OF WORK.
ANY DISCREPANCIES TO BE BROUGHT TO THE ATTENTION OF THE ARCHITECT.
DIMENSIONS ARE INDICATED IN MILLIMETERS.



REV	DATE	DESCRIPTION


PRINCIPAL AGENT

PRINCIPAL AGENT
LOGO HERE

DISCIPLINE


ARCHITECT LOGO HERE


PROJECT DESCRIPTION	IMPLEMENTING PROGRAMME	DRAWING NUMBER	GROUND FLOOR PLAN
DOCUMENT STATUS	DOCUMENT STATUS	DRAWING NUMBER	0000_AR_EE1_201
PROJECT NUMBER	0000	DWG	CHK
DATE	01/01/23	SCALE	As indicated

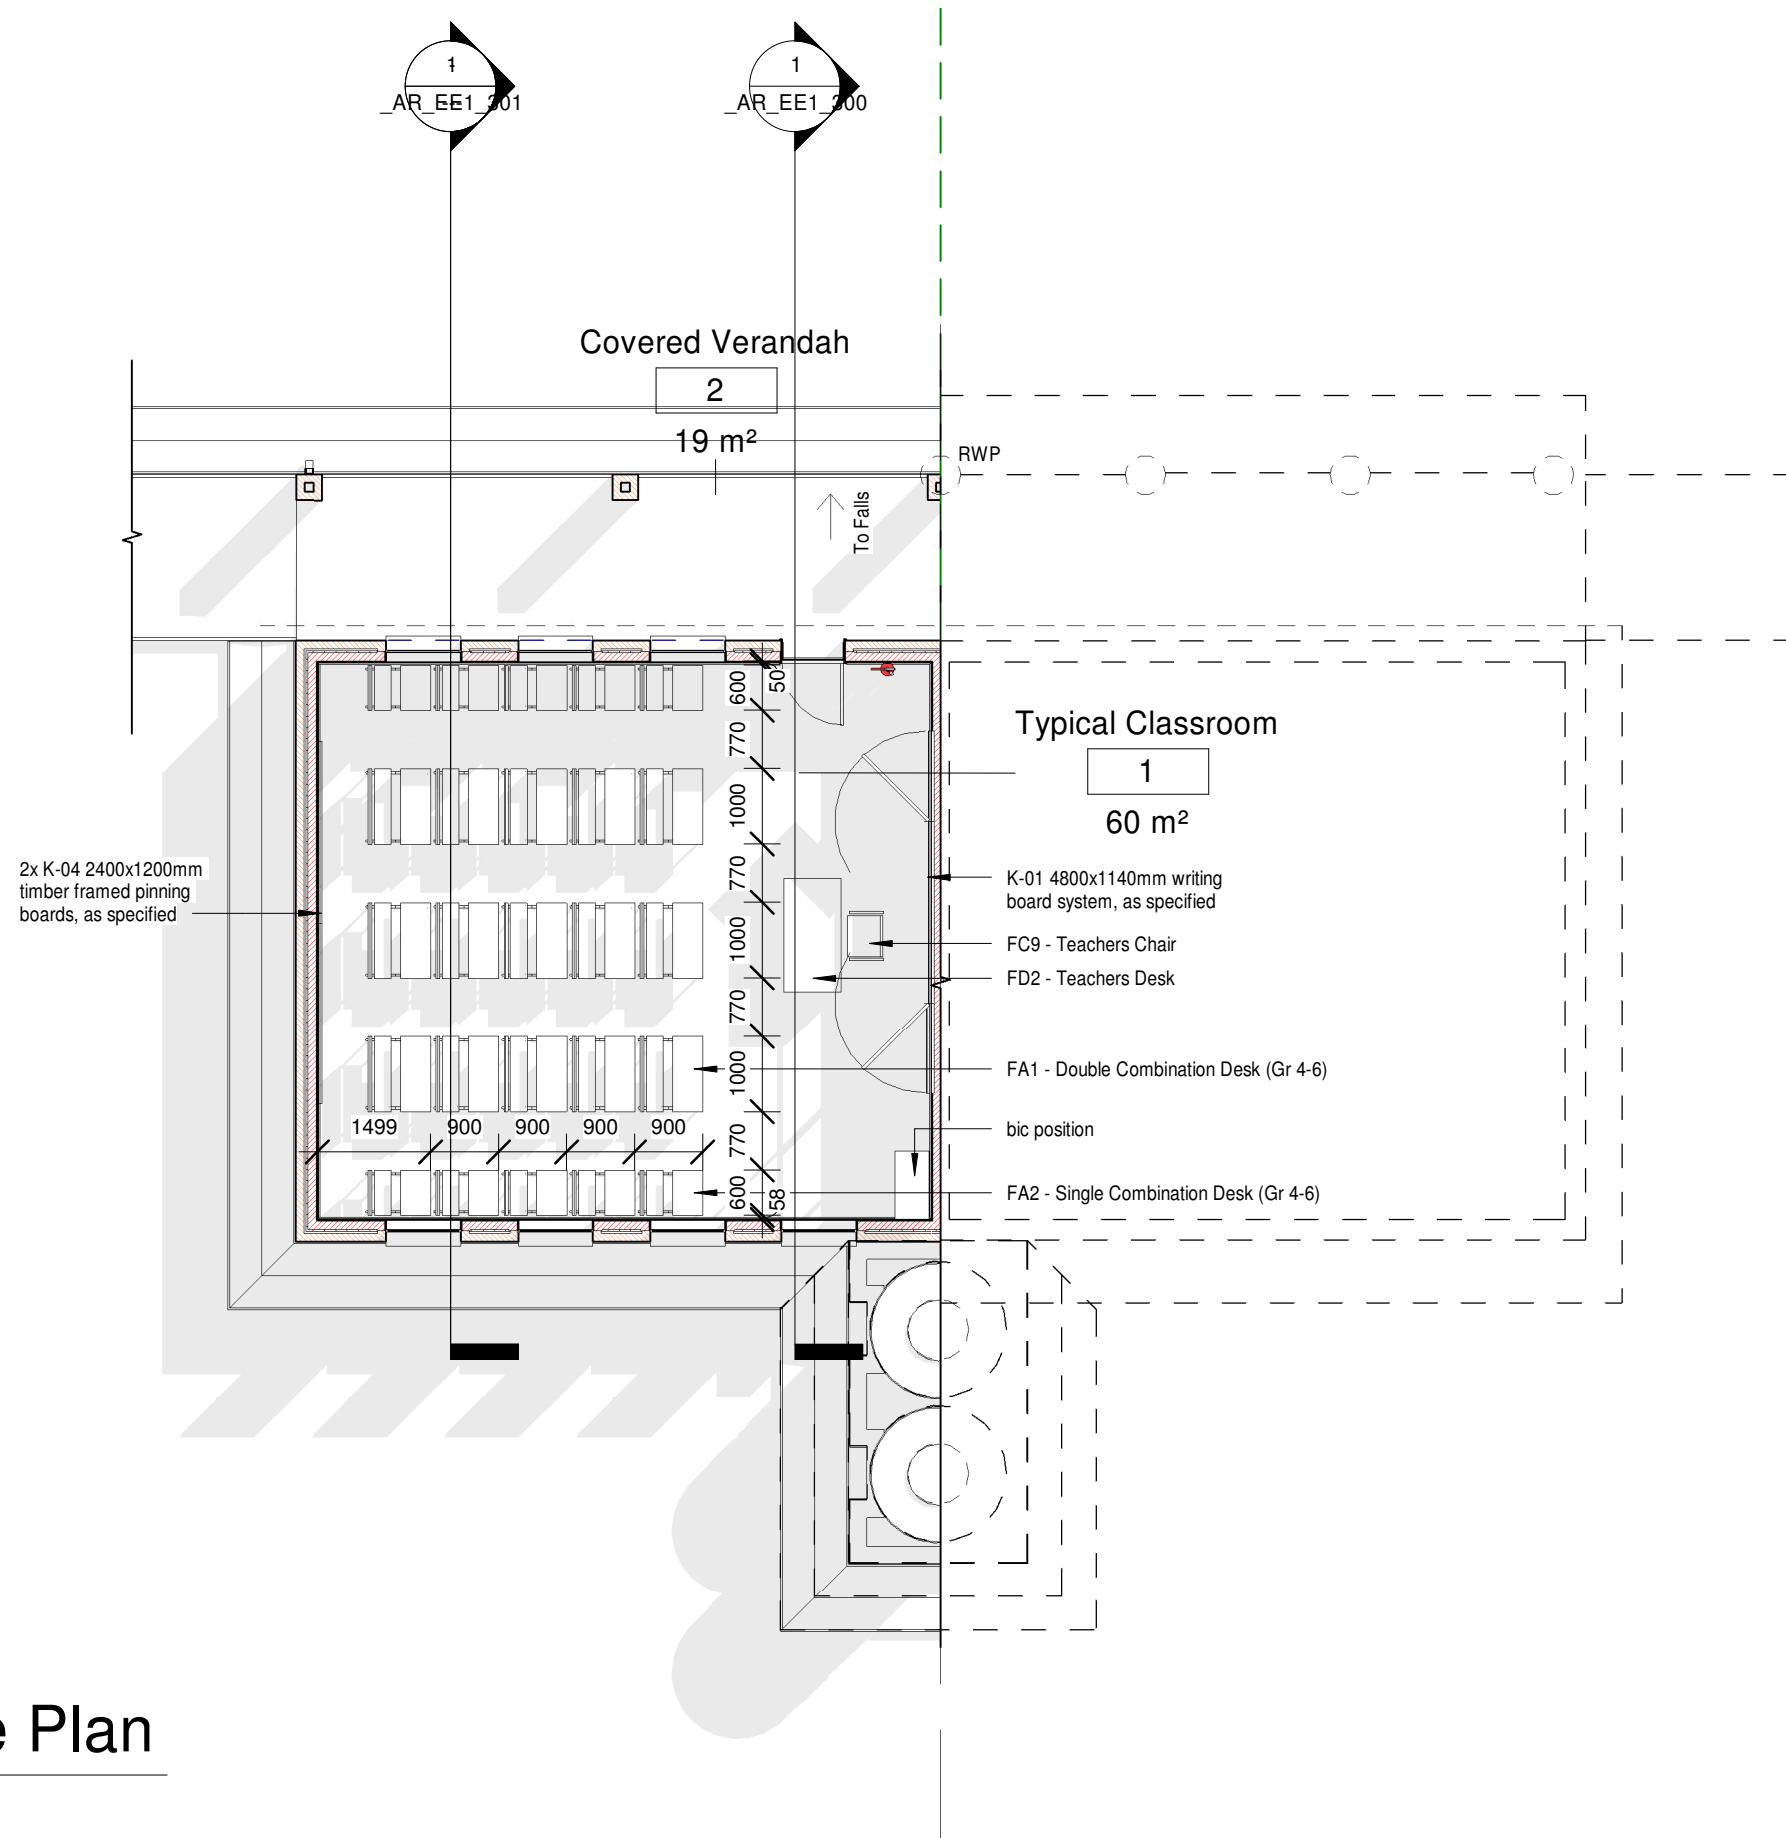


1 Furniture Plan
1 : 100




COPYRIGHT NOTE	<ul style="list-style-type: none">THIS DRAWING IS SUBJECT TO COPYRIGHT AND MAY NOT BE REPRODUCED, IN WHOLE OR PART, OR IN ANY MANNER WHATSOEVER WITHOUT WRITTEN PERMISSION FROM THE ARCHITECT.ALL WORK TO BE CARRIED OUT STRICTLY IN ACCORDANCE WITH MUNICIPAL AND/OR LOCAL AUTHORITY REGULATIONS. DO NOT SCALE THIS DRAWING. FIGURED DIMENSIONS TO BE TAKEN IN.PREFERENCE TO SCALING DRAWING.ALL RELEVANT DETAILS, LEVELS, AND DIMENSIONS TO BE CHECKED ON SITE PRIOR TO COMMENCEMENT OF WORK.ANY DISCREPANCIES TO BE BROUGHT TO THE ATTENTION OF THE ARCHITECT. DIMENSIONS ARE INDICATED IN MILLIMETERS.	<div>COPYRIGHT</div> <div><div>basic education</div><div>Department: Basic Education REPUBLIC OF SOUTH AFRICA</div></div>	<table><thead><tr><th>REV</th><th>DATE</th><th>DESCRIPTION</th></tr></thead><tbody><tr><td> </td><td> </td><td> </td></tr><tr><td> </td><td> </td><td> </td></tr><tr><td> </td><td> </td><td> </td></tr><tr><td> </td><td> </td><td> </td></tr><tr><td> </td><td> </td><td> </td></tr><tr><td> </td><td> </td><td> </td></tr></tbody></table>			REV	DATE	DESCRIPTION																			PRINCIPAL AGENT	<div>PRINCIPAL AGENT LOGO HERE</div>	DISCIPLINE	<div>ARCHITECT LOGO HERE</div>	PROJECT DESCRIPTION	IMPLEMENTING PROGRAMME		DRAWING DESCRIPTION	3D PERSPECTIVE	
			REV	DATE	DESCRIPTION																															
DOCUMENT STATUS	DOCUMENT STATUS		DRAWING NUMBER	0000_AR_EE1_205																																
PROJECT NUMBER	0000		DRAWING NUMBER	PROJECT NUMBER	DRAWING NUMBER	DATE	01/01/23	SCALE	REVISION																											
DWG	CHK	DATE	01/01/23	SCALE	REVISION																															

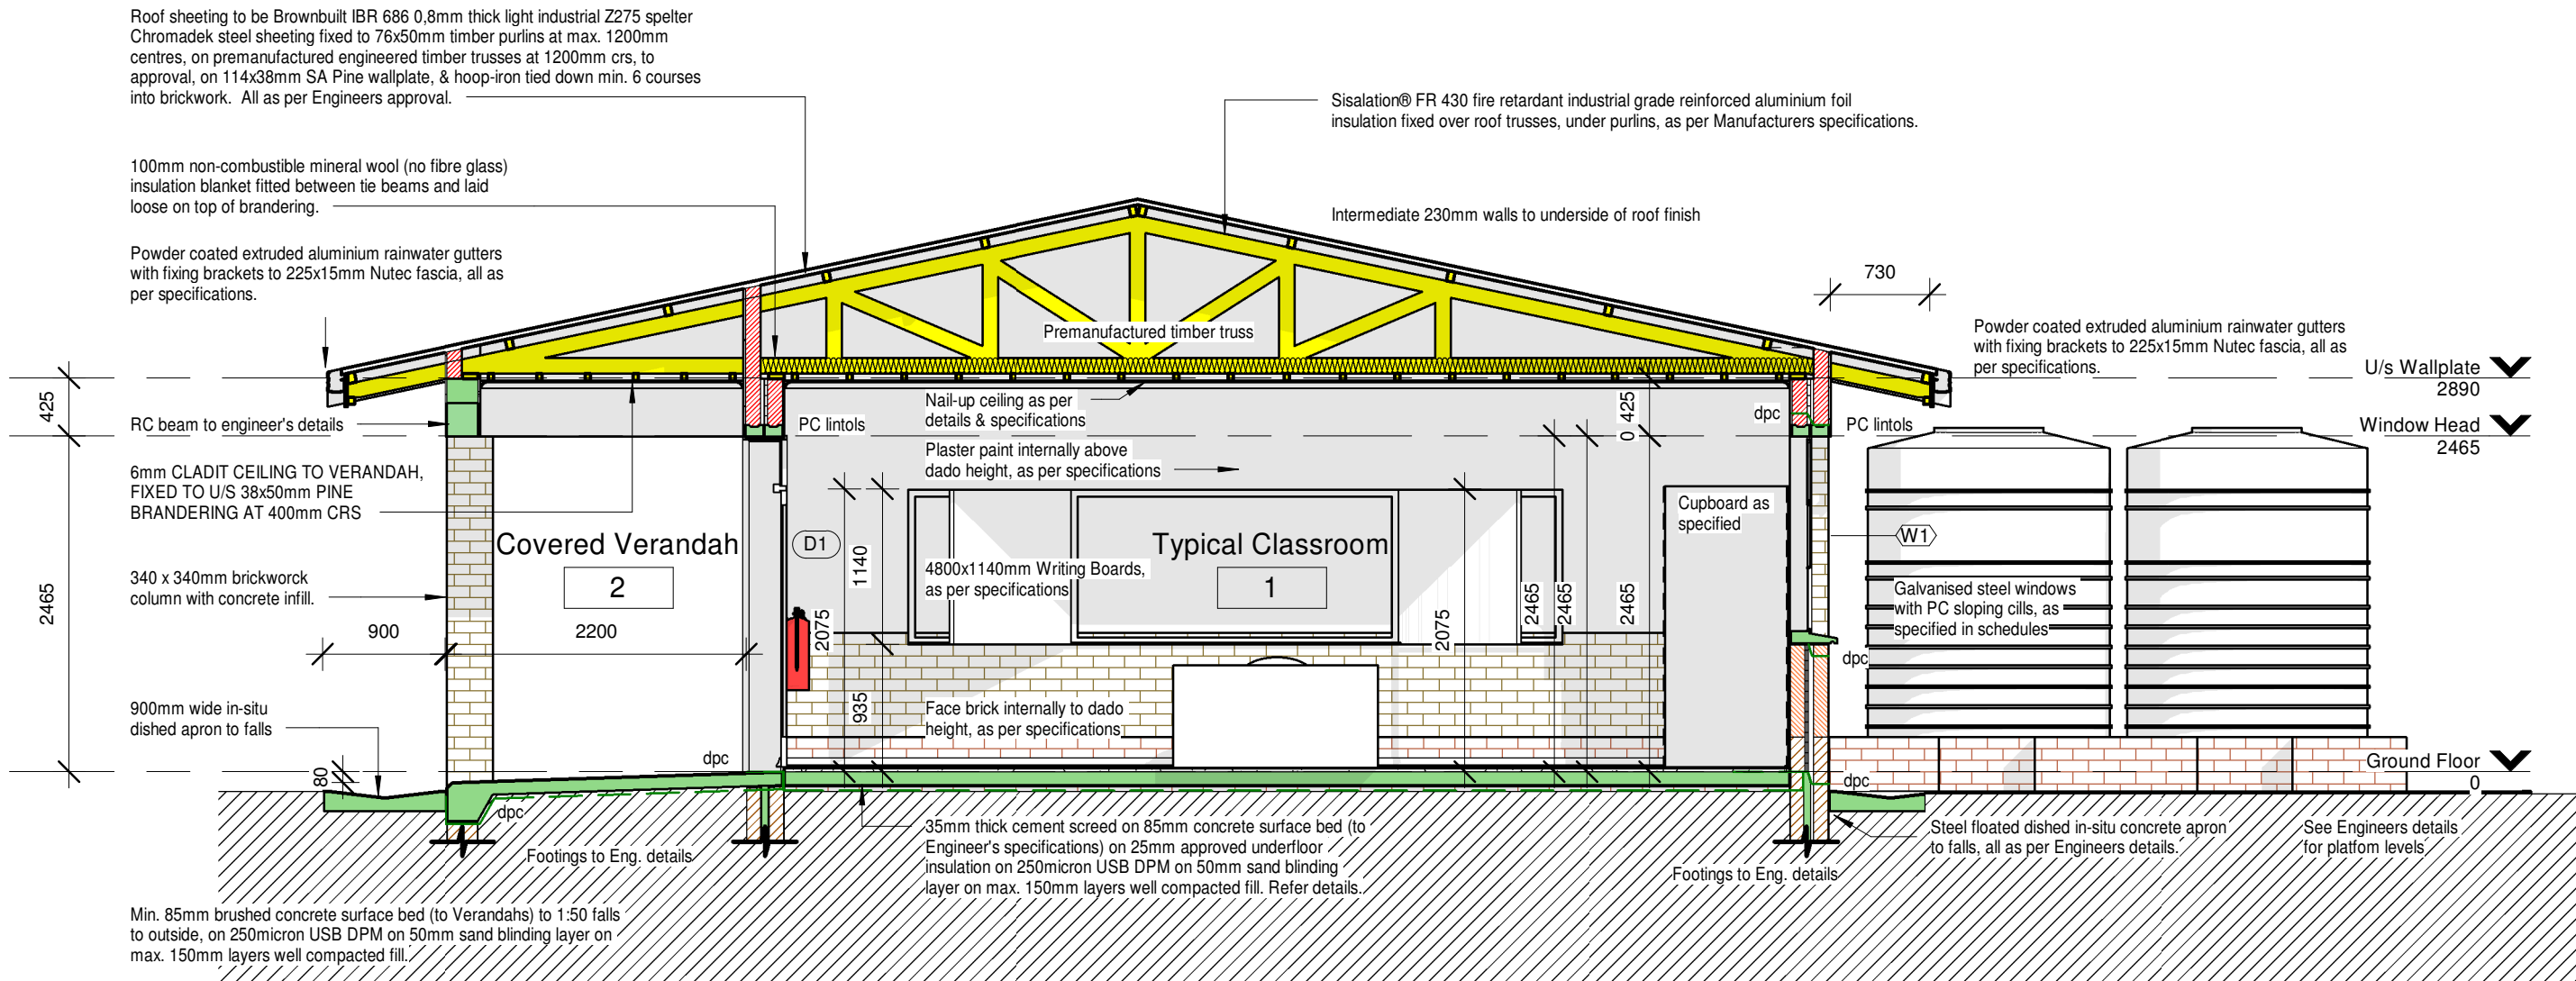

Section 1
1 : 50

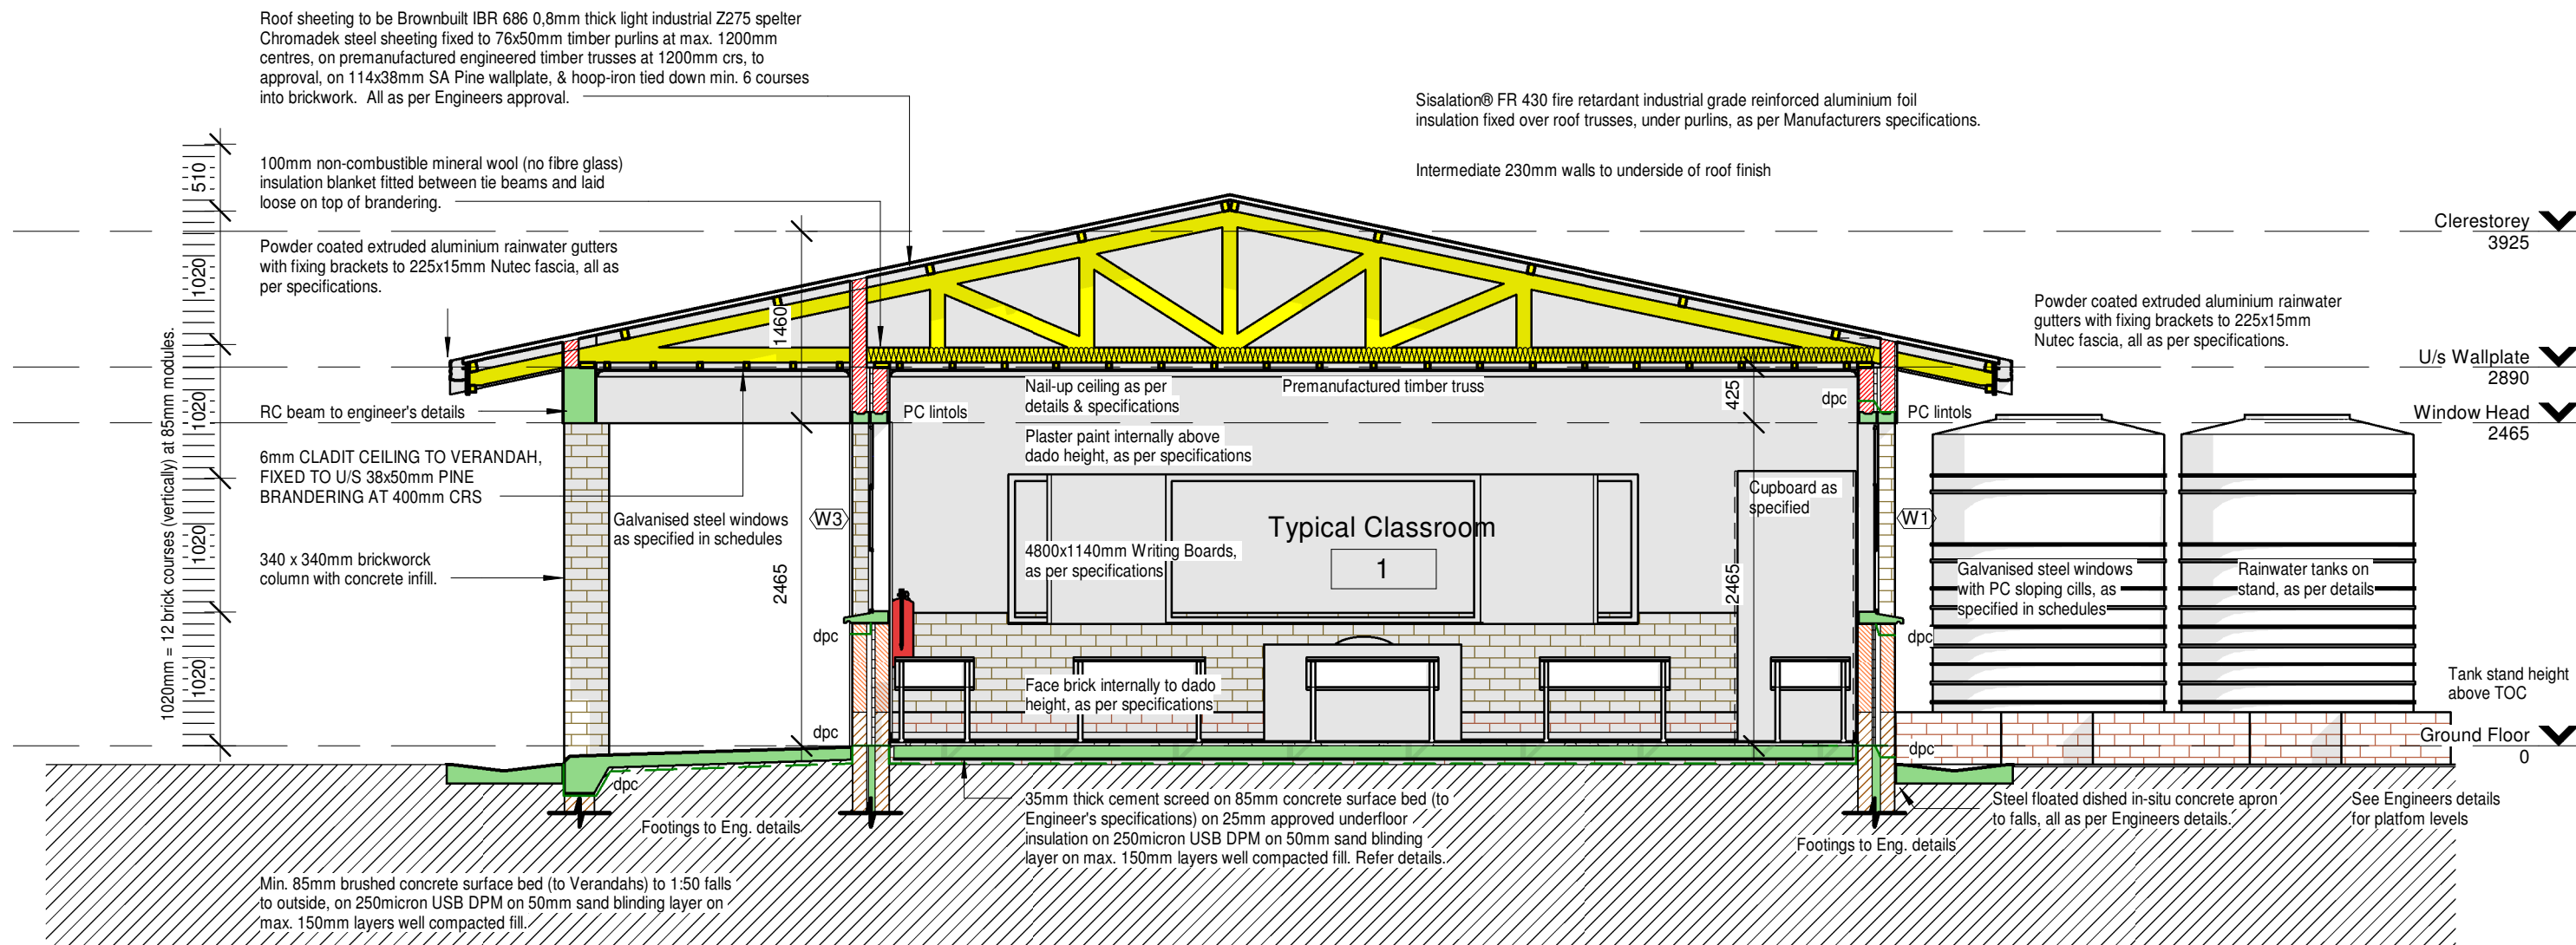

1 Section 2
1 : 50

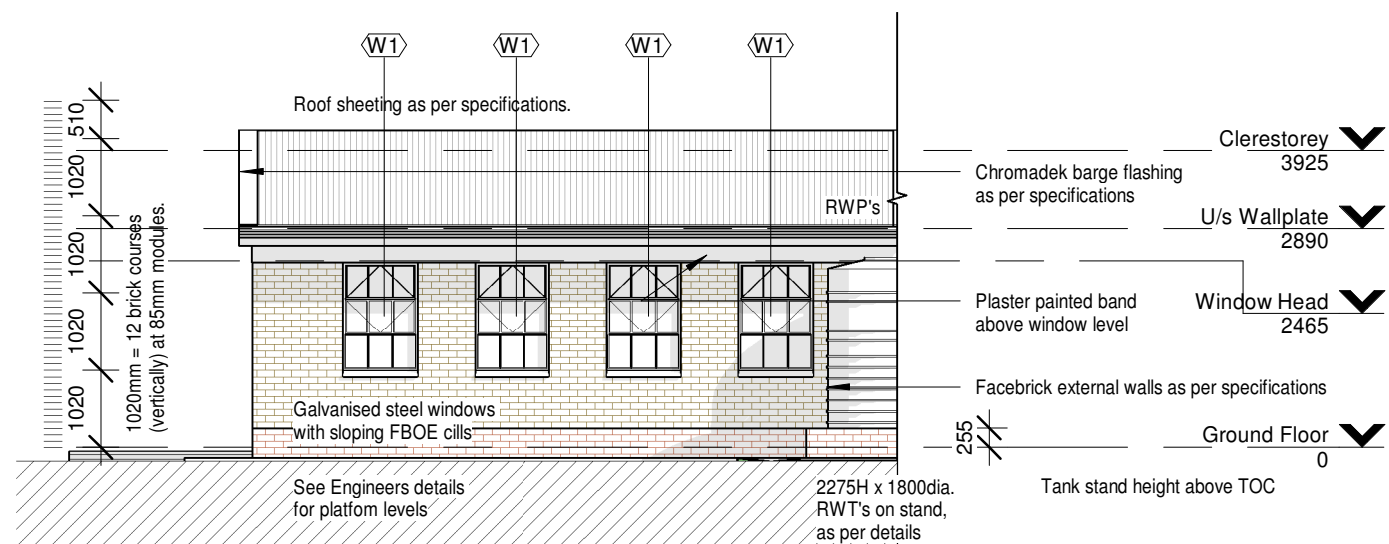

ELEVATION-1

1


1 : 100



ELEVATION-3

3

1 : 100

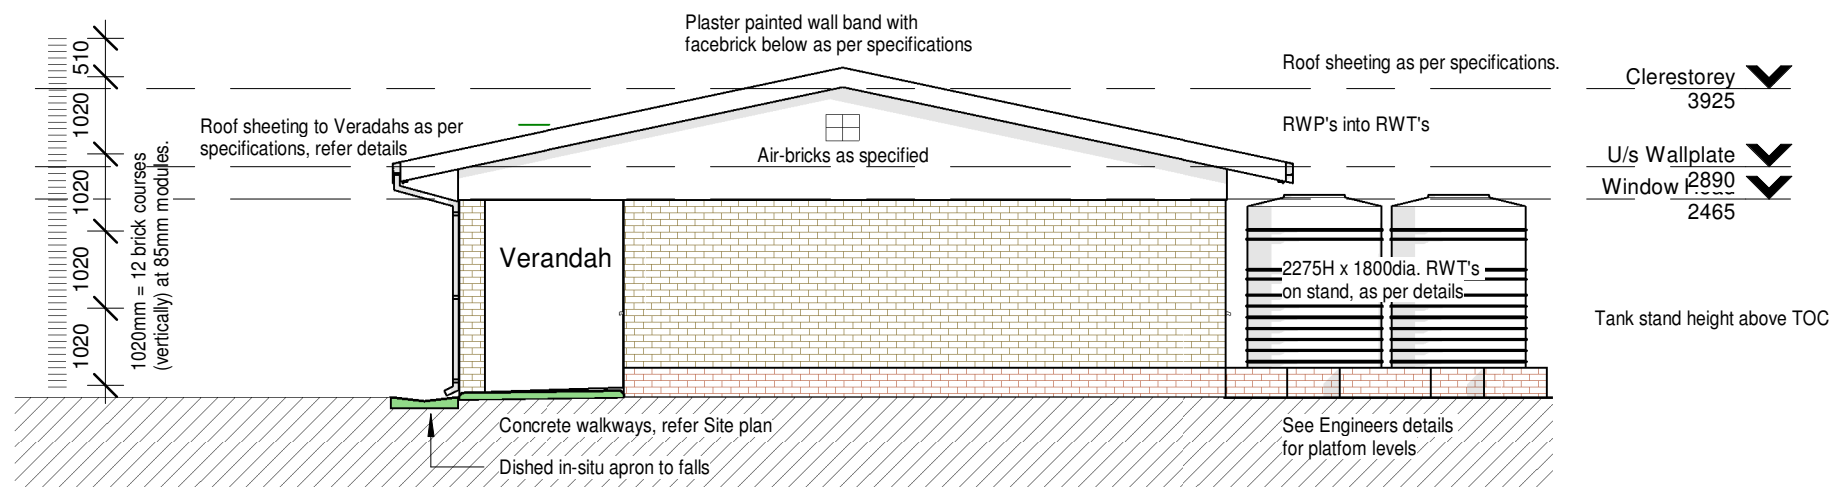

ELEVATION-2

2

1 : 100

THIS DRAWING IS SUBJECT TO COPYRIGHT AND MAY NOT BE REPRODUCED, IN WHOLE OR PART, OR IN ANY MANNER WHATSOEVER WITHOUT WRITTEN PERMISSION FROM THE ARCHITECT.
ALL WORK TO BE CARRIED OUT STRICTLY IN ACCORDANCE WITH MUNICIPAL AND/OR LOCAL AUTHORITY REGULATIONS.
DO NOT SCALE THIS DRAWING. FIGURED DIMENSIONS TO BE TAKEN IN.
PREFERENCE TO SCALING DRAWING.
ALL RELEVANT DETAILS, LEVELS, AND DIMENSIONS TO BE CHECKED ON SITE PRIOR TO COMMENCEMENT OF WORK.
ANY DISCREPANCIES TO BE BROUGHT TO THE ATTENTION OF THE ARCHITECT.
DIMENSIONS ARE INDICATED IN MILLIMETERS.



basic education
Department:
Basic Education
REPUBLIC OF SOUTH AFRICA

REV	DATE	DESCRIPTION

PRINCIPAL AGENT

PRINCIPAL AGENT
LOGO HERE

DISCIPLINE

ARCHITECT LOGO HERE

PROJECT DESCRIPTION	IMPLEMENTING PROGRAMME	DRAWING DESCRIPTION	ELEVATIONS
DOCUMENT STATUS	DOCUMENT STATUS	DRAWING NUMBER	0000_AR_EE1_400
PROJECT NUMBER	0000	DWG	CHK
DATE	01/01/23	SCALE	1 : 100


DOOR TYPE:		D1	QUANTITY:	FRAME DESCRIPTION:	
<div></div>				285mm standard 1.6mm galvanised steel door frame double rebated for 285mm brick wall. NOTE: Frame to be inclusive off 3x GMS hinges by Manufacturer & striker plate with sash & mortise.	
				FRAME FINISH:	
				One coat primer One undercoat, and 2 coats low gloss non-drip enamel, as per Finishing Schedule	
				DOOR DESCRIPTION:	
				813x2032mm x 44mm thick FLB&B door. Add 6mm Marine Ply recessed to inside face. Ex 70x32mm weather board Threshold reeded & to fall 6mm to outside.	
				DOOR FINISH:	
				One coat wood primer One undercoat, and 2 coats low gloss non-drip enamel, as per Finishing Schedule, all in accordance with the manufacturer's recommendations.	
				NOTES:	
				Hinges & frame to be supplied for approval prior to installation. 6.38mm clear laminated safety glass to fixed fanlight.	
				DOOR HANDING / LEGEND:	
<div></div>				<div></div>	
BUILDING No:		SCALE 1:25			
DOOR No:					
DOOR LOCATION:					
REFER TO BUILDING K.O.P. SCHEDULE					
IRONMONGERY:					
<div>Hinges: 3x factory fitted, as supplied by frame Manufacturer (Architect to approve sample before installation on site) Locks: Three lever mortice lockset as "Union 2277-78" with striking plate fixed to steel door frame. Door handles: "Union" "Protea" CB612-24SC brass lever furniture. Sundries: "Union" CZ8731SC door stop.</div>					

[illegible]



basic education

Department:
Basic Education
REPUBLIC OF SOUTH AFRICA

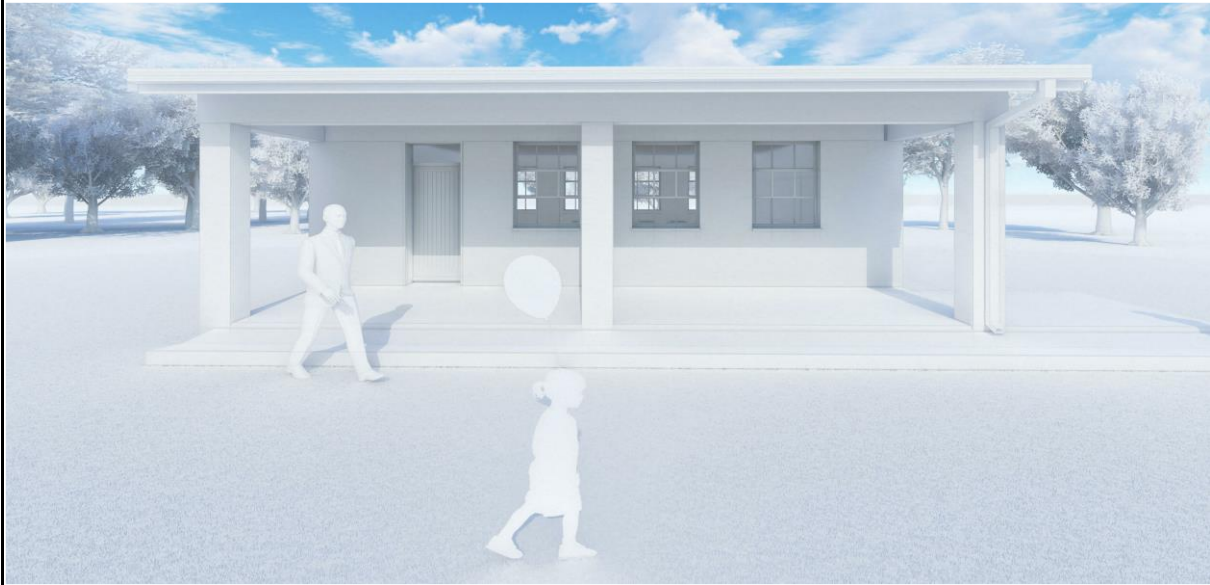

DEPARTMENT OF BASIC EDUCATION DESIGN REVIEWS: CLASSROOMS (EE1)

INDICATIVE CONSTRUCTION COST ESTIMATE NO 1

Prepared by:



QUANTITY SURVEYORS

84 Cape Road, Mill Park, Port Elizabeth
Contact: 041 373 9127 ; Email: janitas@btkm.co.za

REVISION	0
DATE	19 Oct 23

INDICATIVE ESTIMATE OF CONSTRUCTION COST REV 0

NO	SECTION / ELEMENT	SUB-TOTAL	TOTAL
1	BUILDING WORKS		R726 307
1.1	Earthworks	R51 339	
1.2	Concrete, formwork and reinforcing	R69 110	
1.3	Precast concrete	R560	
1.4	Masonry	R159 084	
1.5	Waterproofing	R9 122	
1.6	Roof coverings	R70 384	
1.7	Carpentry and Joinery	R62 289	
1.8	Ceilings, Partitions and Access Flooring	R39 034	
1.9	Loose Furniture	R66 310	
1.10	Floor Coverings	R44 225	
1.11	Ironmongery	R67 934	
1.12	Metalwork	R25 750	
1.13	Plastering	R27 344	
1.14	Tiling	R0	
1.15	Plumbing and Drainage	R3 321	
1.16	Glazing	R6 171	
1.17	Paintwork	R24 328	
2	External Works		R45 000
2.1	Earthworks & Platforms	R27 000	
2.2	V-Channels & Aprons	R18 000	
3	Specialist Installations		R32 000
3.1	Electrical Installation	R32 000	
	ESTIMATED CONSTRUCTION COST EXCLUDING VAT		R803 307
4	Add: VAT @ 15%	15%	R120 500
	ESTIMATED CONSTRUCTION COST INCLUDING VAT		R923 807
	R/ m2 of Construction Area incl VAT	68m2	R 13 585
	R/ m2 of Construction Area excl VAT	68m2	R 11 813

PLEASE REFER TO ESTIMATE NOTES, ASSUMPTIONS AND EXCLUSIONS ON PAGE 3

INDICATIVE ESTIMATE OF CONSTRUCTION COST REV 0 - NOTES AND ASSUMPTIONS

1.0 DESIGN AND COST PARAMETERS

The Estimated Costs are based on the following parameters:

- 1.1 Estimate is based on the drawings for Building Code EE1 : CLASSROOMS
- 1.2 Costs are based on current market conditions, typical norms and similar building types
- 1.3 The estimated costs are indicative only and are subject to adjustment in accordance with the design development.

2.0 ASSUMPTIONS

For the purpose of this analysis the following site conditions are assumed:

- 2.1 The erf is relatively flat with no extreme site conditions present
- 2.2 5 % Hardrock allowance is made
- 2.3 10% Softrock allowance is made

3.0 EXCLUSIONS

The following are excluded from the Estimated Improvement Costs:


- 4.1 Site reticulation for electrical, plumbing & drainage services connections
 - 4.2 Any demolitions and/or removal of existing work on existing site
 - 4.3 Blinds and curtains
 - 4.4 Preliminaries
 - 4.5 CPAP
 - 4.6 Professional fees
-

COPYRIGHT NOTE

- THIS DRAWING IS SUBJECT TO COPYRIGHT AND MAY NOT BE REPRODUCED, IN WHOLE OR PART, OR IN ANY MANNER WHATSOEVER WITHOUT WRITTEN PERMISSION FROM THE ARCHITECT.
- ALL WORK TO BE CARRIED OUT STRICTLY IN ACCORDANCE WITH MUNICIPAL AND/OR LOCAL AUTHORITY REGULATIONS. DO NOT SCALE THIS DRAWING. FIGURED DIMENSIONS TO BE TAKEN IN
- PREFERENCE TO SCALING DRAWING.
- ALL RELEVANT DETAILS, LEVELS, AND DIMENSIONS TO BE CHECKED ON SITE PRIOR TO COMMENCEMENT OF WORK.
- ANY DISCREPANCIES TO BE BROUGHT TO THE ATTENTION OF THE ARCHITECT.

DIMENSIONS ARE INDICATED IN MILLIMETERS.

CLIENT



basic education

Department:
Basic Education
REPUBLIC OF SOUTH AFRICA

REV	DATE	DESCRIPTION

PRINCIPAL AGENT

PRINCIPAL AGENT
LOGO HERE

DICIPLINE

ENGINEERS LOGO HERE

PROJECT NUMBER	PROJECT DESCRIPTION
DOCUMENT STATUS	IMPLEMENTING PROGRAMME
DRAWING NUMBER	DRAWING DESCRIPTION
0000	ELECTRICAL - PLUG LAYOUT

DRAWING NUMBER	0000_EE_EE1_800	REVISION
PROJECT NUMBER	PROJECT DESCRIPTION	DRAWING NUMBER

DRAWING	CHK	DATE	SCALE
0000	01/01/23		

COPYRIGHT NOTE

- THIS DRAWING IS SUBJECT TO COPYRIGHT AND MAY NOT BE REPRODUCED, IN WHOLE OR PART, OR IN ANY MANNER WHATSOEVER, WITHOUT WRITTEN PERMISSION FROM THE ARCHITECT.
- ALL WORK TO BE CARRIED OUT STRICTLY IN ACCORDANCE WITH MUNICIPAL AND/OR LOCAL AUTHORITY REGULATIONS
- DO NOT SCALE THIS DRAWING. FIGURED DIMENSIONS TO BE TAKEN IN
- PREFERENCE TO SCALING DRAWING.
- ALL RELEVANT DETAILS, LEVELS, AND DIMENSIONS TO BE CHECKED ON SITE PRIOR TO COMMENCEMENT OF WORK
- ANY DISCREPANCIES TO BE BROUGHT TO THE ATTENTION OF THE ARCHITECT
- DIMENSIONS ARE INDICATED IN MILLIMETERS.



CLIENT	 <div> basic education </div> <div> Department: Basic Education REPUBLIC OF SOUTH AFRICA </div>
	<div> Department: Basic Education REPUBLIC OF SOUTH AFRICA </div>

[illegible]

PRINCIPAL AGENT

**PRINCIPAL AGENT
LOGO HERE**


DICIPLINE



ENGINEERS LOGO HERE

PROJECT DESCRIPTION	IMPLEMENTING PROGRAMME	DRAWING DESCRIPTION	ELECTRICAL - LIGHTING LAYOUT			
DOCUMENT STATUS	DOCUMENT STATUS	DRAWING NUMBER	0000_EE_EE1_801			REVISION
PROJECT NUMBER	0000	DRAWN	CHECK	DATE	01/01/23	
		DATE	DATE	DATE	SCALE	




COPYRIGHT NOTE	<div><div></div><div><div>basic education</div><div>Department: Basic Education REPUBLIC OF SOUTH AFRICA</div></div></div>	<table><tr><th>REV</th><th>DATE</th><th>DESCRIPTION</th></tr><tr><td> </td><td> </td><td> </td></tr><tr><td> </td><td> </td><td> </td></tr><tr><td> </td><td> </td><td> </td></tr><tr><td> </td><td> </td><td> </td></tr><tr><td> </td><td> </td><td> </td></tr><tr><td> </td><td> </td><td> </td></tr><tr><td> </td><td> </td><td> </td></tr></table>	REV	DATE	DESCRIPTION																						PRINCIPAL AGENT	<div><div></div><div>PRINCIPAL AGENT LOGO HERE</div><div></div></div>	DISCIPLINE	<div><div></div><div>ENGINEERS LOGO HERE</div><div></div></div>	<table><tr><td>PROJECT NUMBER</td><td>PROJECT DESCRIPTION</td></tr><tr><td>0000</td><td>IMPLEMENTING PROGRAMME</td></tr></table>	PROJECT NUMBER	PROJECT DESCRIPTION	0000	IMPLEMENTING PROGRAMME	<table><tr><td>DRAWING NUMBER</td><td>DRAWING DESCRIPTION</td></tr><tr><td>0000</td><td>ELECTRICAL - SCHEMATIC DETAILS</td></tr></table>	DRAWING NUMBER	DRAWING DESCRIPTION	0000	ELECTRICAL - SCHEMATIC DETAILS
		REV	DATE	DESCRIPTION																																				
PROJECT NUMBER	PROJECT DESCRIPTION																																							
0000	IMPLEMENTING PROGRAMME																																							
DRAWING NUMBER	DRAWING DESCRIPTION																																							
0000	ELECTRICAL - SCHEMATIC DETAILS																																							
<table><tr><td>PROJECT NUMBER</td><td>DOCUMENT STATUS</td></tr><tr><td>0000</td><td>DOCUMENT STATUS</td></tr></table>	PROJECT NUMBER	DOCUMENT STATUS	0000	DOCUMENT STATUS	<table><tr><td>DRAWING NUMBER</td><td>PROJECT NUMBER</td><td>DISCIPLINE</td><td>DRAWING NUMBER</td></tr><tr><td>0000</td><td>0000</td><td>EE</td><td>EE1_802</td></tr></table>	DRAWING NUMBER	PROJECT NUMBER	DISCIPLINE	DRAWING NUMBER	0000	0000	EE	EE1_802	REVISION																										
PROJECT NUMBER	DOCUMENT STATUS																																							
0000	DOCUMENT STATUS																																							
DRAWING NUMBER	PROJECT NUMBER	DISCIPLINE	DRAWING NUMBER																																					
0000	0000	EE	EE1_802																																					
<table><tr><td>DRAWING NUMBER</td><td>CHECK NUMBER</td><td>DATE</td><td>SCALE</td></tr><tr><td>DWG</td><td>CHK</td><td>01/01/23</td><td> </td></tr></table>	DRAWING NUMBER	CHECK NUMBER	DATE	SCALE	DWG	CHK	01/01/23																																	
DRAWING NUMBER	CHECK NUMBER	DATE	SCALE																																					
DWG	CHK	01/01/23																																						

COPYRIGHT NOTE

- THIS DRAWING IS SUBJECT TO COPYRIGHT AND MAY NOT BE REPRODUCED, IN WHOLE OR PART, OR IN ANY MANNER WHATSOEVER WITHOUT WRITTEN PERMISSION FROM THE ARCHITECT.
- ALL WORK TO BE CARRIED OUT STRICTLY IN ACCORDANCE WITH MUNICIPAL AND/OR LOCAL AUTHORITY REGULATIONS. DO NOT SCALE THIS DRAWING. FIGURED DIMENSIONS TO BE TAKEN IN
- PREFERENCE TO SCALING DRAWING.
- ALL RELEVANT DETAILS, LEVELS, AND DIMENSIONS TO BE CHECKED ON SITE PRIOR TO COMMENCEMENT OF WORK.
- ANY DISCREPANCIES TO BE BROUGHT TO THE ATTENTION OF THE ARCHITECT.

DIMENSIONS ARE INDICATED IN MILLIMETERS.

CLIENT



basic education

Department:
Basic Education
REPUBLIC OF SOUTH AFRICA

REV	DATE	DESCRIPTION

PRINCIPAL AGENT

PRINCIPAL AGENT
LOGO HERE

DICIPLINE

ENGINEERS LOGO HERE

PROJECT NUMBER	PROJECT DESCRIPTION
DOCUMENT STATUS	IMPLEMENTING PROGRAMME
DRAWING NUMBER	STRUCTURAL - FOUNDATIONS & DETAILS
0000	


DRAWING NUMBER	0000_SE_EE1_700	REVISION	
PROJECT NUMBER	PROJECT DESCRIPTION	DRAWING NUMBER	
DWG	CHK	DATE	01/01/23
DETAILS	DETAILS	DAY	MONTH YEAR
SCALE			

COPYRIGHT NOTE

- THIS DRAWING IS SUBJECT TO COPYRIGHT AND MAY NOT BE REPRODUCED, IN WHOLE OR PART, OR IN ANY MANNER WHATSOEVER WITHOUT WRITTEN PERMISSION FROM THE ARCHITECT.
- ALL WORK TO BE CARRIED OUT STRICTLY IN ACCORDANCE WITH MUNICIPAL AND/OR LOCAL AUTHORITY REGULATIONS. DO NOT SCALE THIS DRAWING. FIGURED DIMENSIONS TO BE TAKEN IN
- PREFERENCE TO SCALING DRAWING.
- ALL RELEVANT DETAILS, LEVELS, AND DIMENSIONS TO BE CHECKED ON SITE PRIOR TO COMMENCEMENT OF WORK.
- ANY DISCREPANCIES TO BE BROUGHT TO THE ATTENTION OF THE ARCHITECT.

DIMENSIONS ARE INDICATED IN MILLIMETERS.

CLIENT



basic education

Department:
Basic Education
REPUBLIC OF SOUTH AFRICA

REV	DATE	DESCRIPTION

PRINCIPAL AGENT

PRINCIPAL AGENT
LOGO HERE

DICIPLINE

ENGINEERS LOGO HERE

PROJECT NUMBER	PROJECT DESCRIPTION
DOCUMENT STATUS	IMPLEMENTING PROGRAMME
DRAWING NUMBER	STRUCTURAL - FLOOR SLAB & DETAILS
0000	

DRAWING NUMBER	0000_SE_EE1_701	REVISION
PROJECT NUMBER	PROJECT DESCRIPTION	DATE
DWG	CHK	01/01/23
SCALE		

COPYRIGHT NOTE

- THIS DRAWING IS SUBJECT TO COPYRIGHT AND MAY NOT BE REPRODUCED, IN WHOLE OR PART, OR IN ANY MANNER WHATSOEVER, WITHOUT WRITTEN PERMISSION FROM THE ARCHITECT.
- ALL WORK TO BE CARRIED OUT STRICTLY IN ACCORDANCE WITH MUNICIPAL AND/OR LOCAL AUTHORITY REGULATIONS
- DO NOT SCALE THIS DRAWING. FIGURED DIMENSIONS TO BE TAKEN IN
- PREFERENCE TO SCALING DRAWING.
- ALL RELEVANT DETAILS, LEVELS, AND DIMENSIONS TO BE CHECKED ON SITE PRIOR TO COMMENCEMENT OF WORK
- ANY DISCREPANCIES TO BE BROUGHT TO THE ATTENTION OF THE ARCHITECT
- DIMENSIONS ARE INDICATED IN MILLIMETERS.



CLIENT	 <div> basic education </div> <div> Department: Basic Education REPUBLIC OF SOUTH AFRICA </div>
	<div> REPUBLIC OF SOUTH AFRICA </div>

[illegible]

PRINCIPAL AGENT

**PRINCIPAL AGENT
LOGO HERE**

DICIPLINE

PROJECT DESCRIPTION	IMPLEMENTING PROGRAMME			DRAWING DESCRIPTION	STRUCTURAL - ROOF & DETAILS						
DOCUMENT STATUS	DOCUMENT STATUS			DRAWING NUMBER	0000_SE_EE1_702				REVISION		
PROJECT NUMBER	0000			DRAWN DATE	CHECK DATE	DATE	01/01/23		SCALE		